


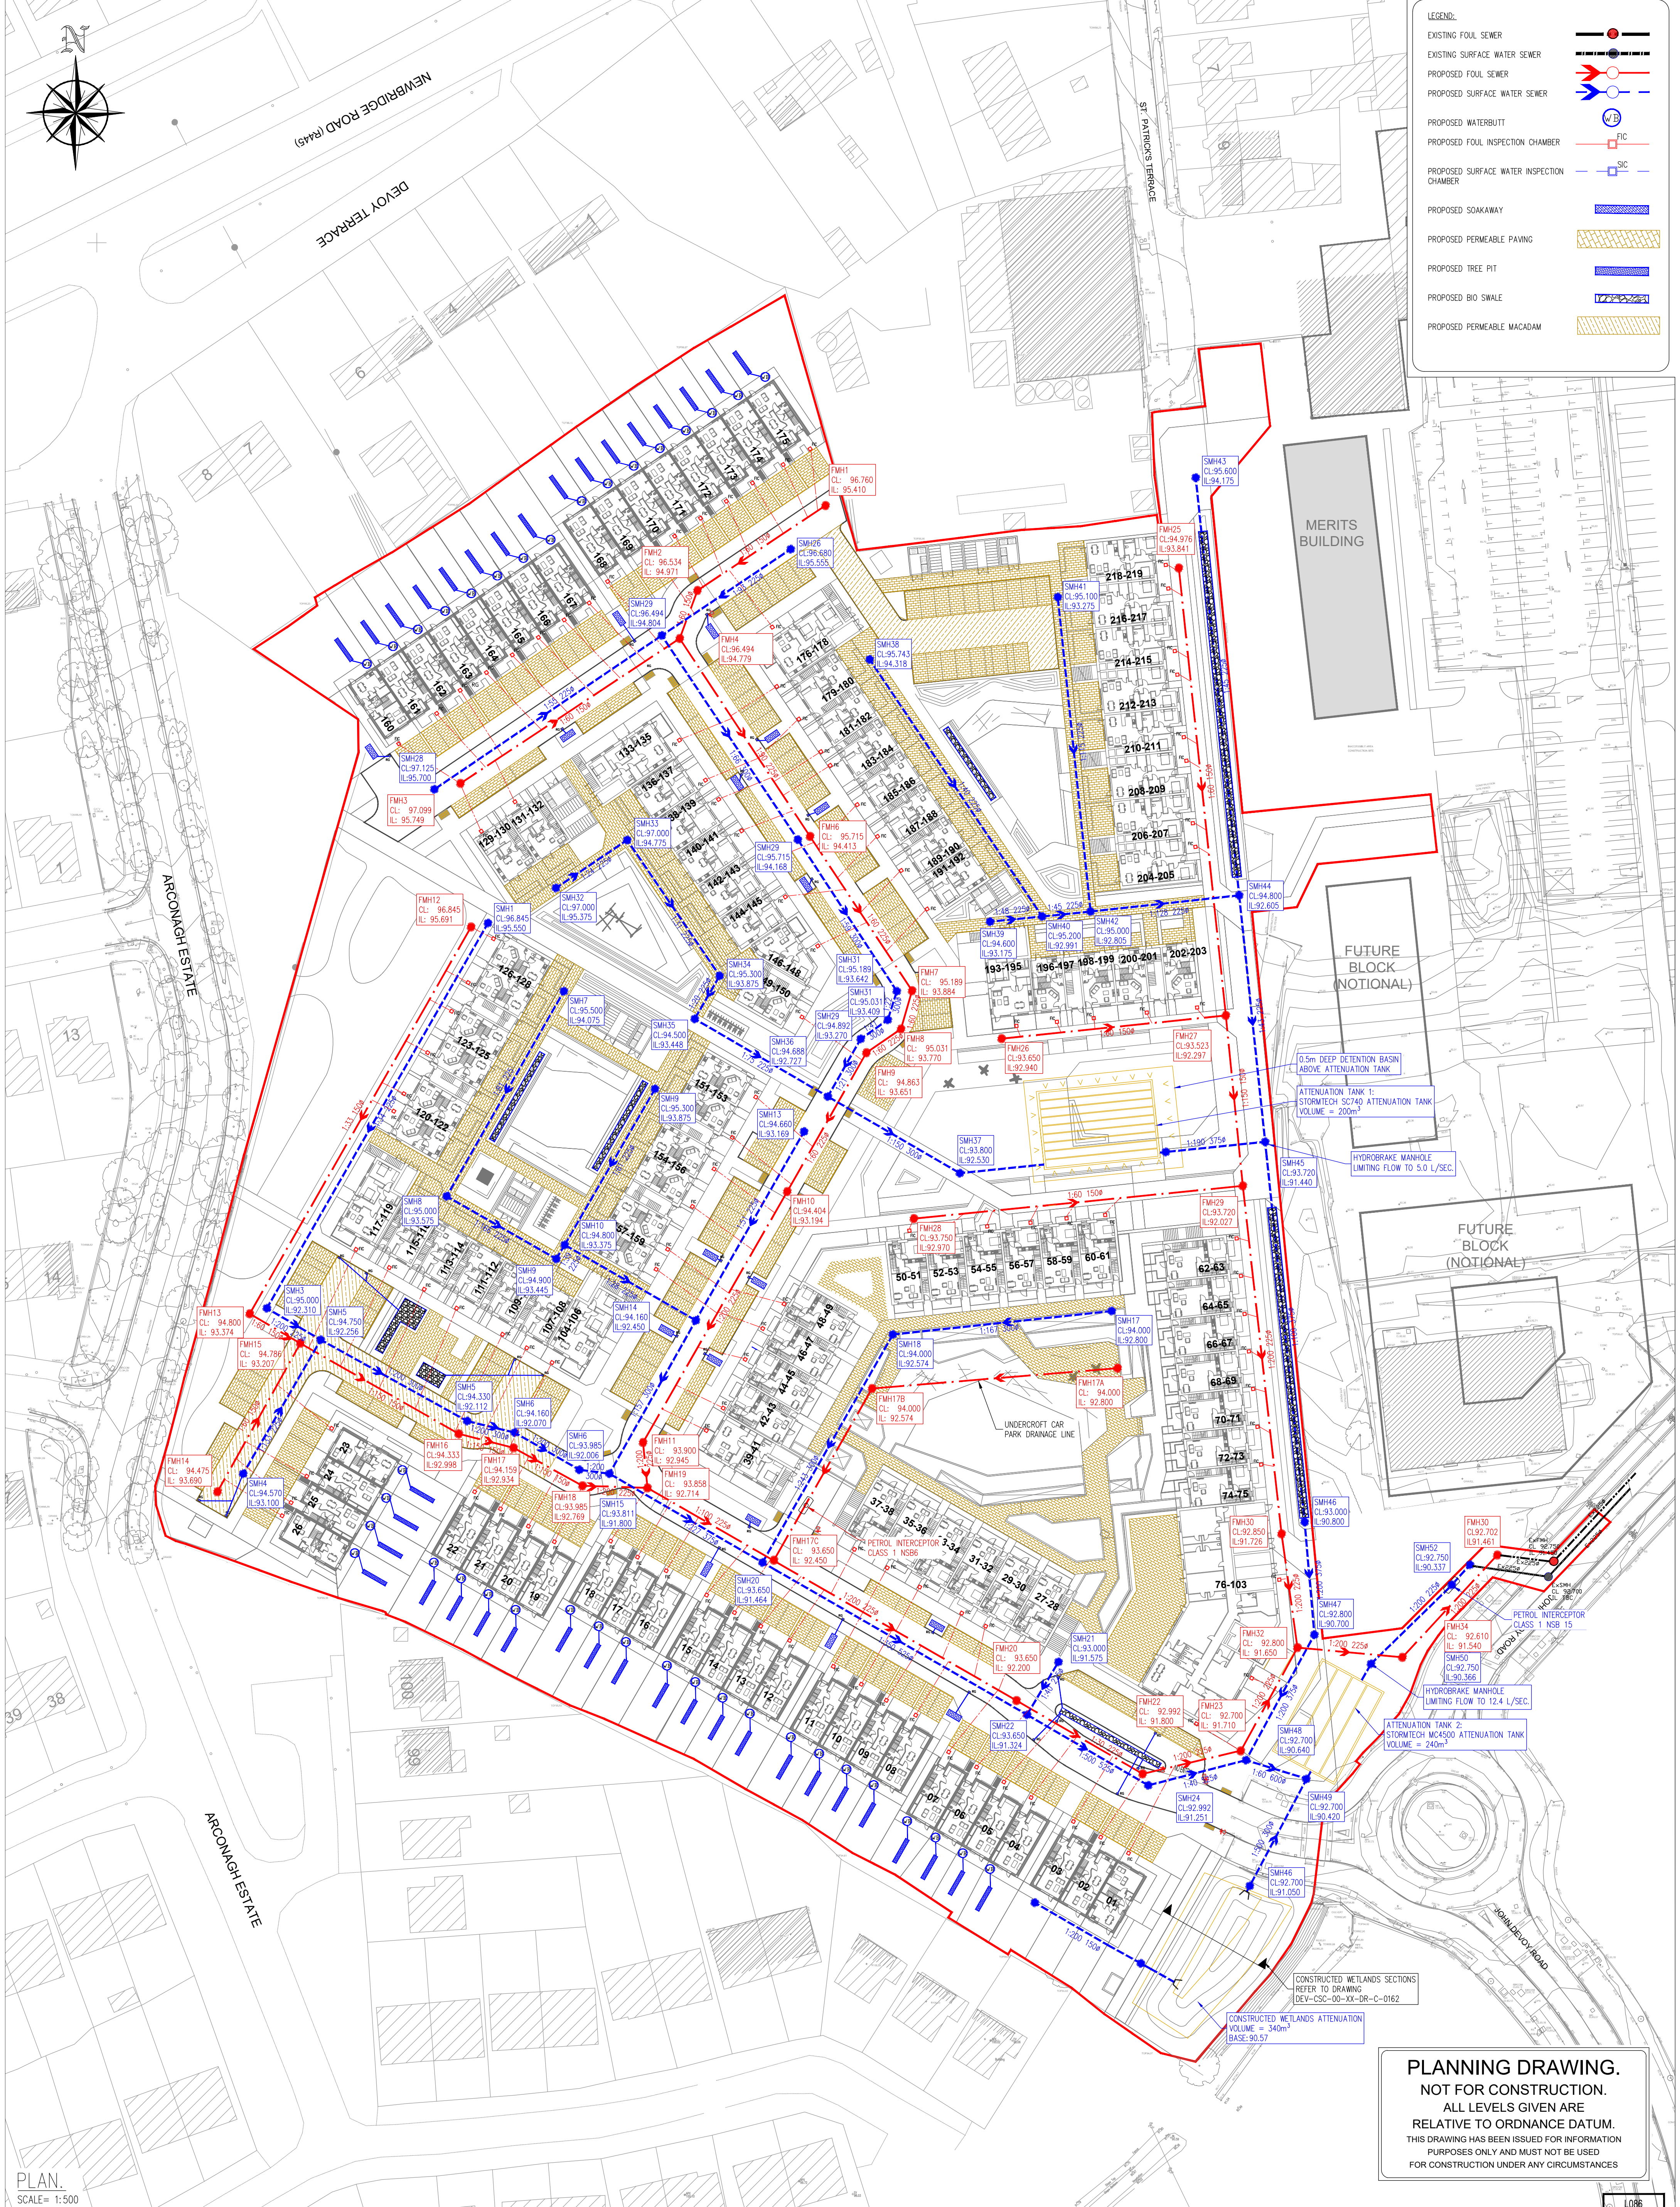

Rev. No.	Date	REVISION NOTE
P11	31.03.2022	REVISED SITE LAYOUT

Rev. No.	Date	REVISION NOTE	Dr. By	Chd. By
P11	31.03.2022	REVISED SITE LAYOUT	AB	GL

Architect:	COADY ARCHITECTS
Project:	DEVELOPMENT AT DEVOY BARRACKS, NAAS
Title:	Proposed Drainage Layout
Dwg. No.	DEV-CSC-00-XX-DR-C-0109
Date	SEPT '20
Dr. by	AB
Chd. by	GL
App'd by	NB
Scale	1:500 @A1
Revision	P11

CS Consulting Group
DUBLIN | LONDON | LIMERICK

Head Office
19-22 Dame Street, Dublin 2.
T: +353 (0)1 5480863
e: info@csconsulting.ie
w: www.csconsulting.ie

Quality
Environment
Health & Safety

I.S. EN ISO 9001:2008
I.S. EN ISO 14001:2004
I.S. EN ISO 50001:2011
OHSAS 18001:2007